



KEN FUSCA DESIGN
 8734 VISTA DEL CANYON #F
 NEWHALL CA 91321
 TEL: (916) 439-9323
HW ENGINEERING
 10930 HOPE HILLS DRIVE
 LAS VEGAS, NV, 89138
 PHONE: 702-799-8800
 FAX: 702-799-8801
 WWW.KENFUSCADESIGN.COM
 WWW.HWENGINEERING.COM

A PROJECT FOR:
LOT SPLIT
 5220 ENCINO AVE
 L.A. CA 91316

REVISIONS	BY

DRAWN BY: NF
 DATE: 03-31-2013
 SCALE: AS SHOWN
 HW ENGINEERING JOB NO: 13002

SHEET
A

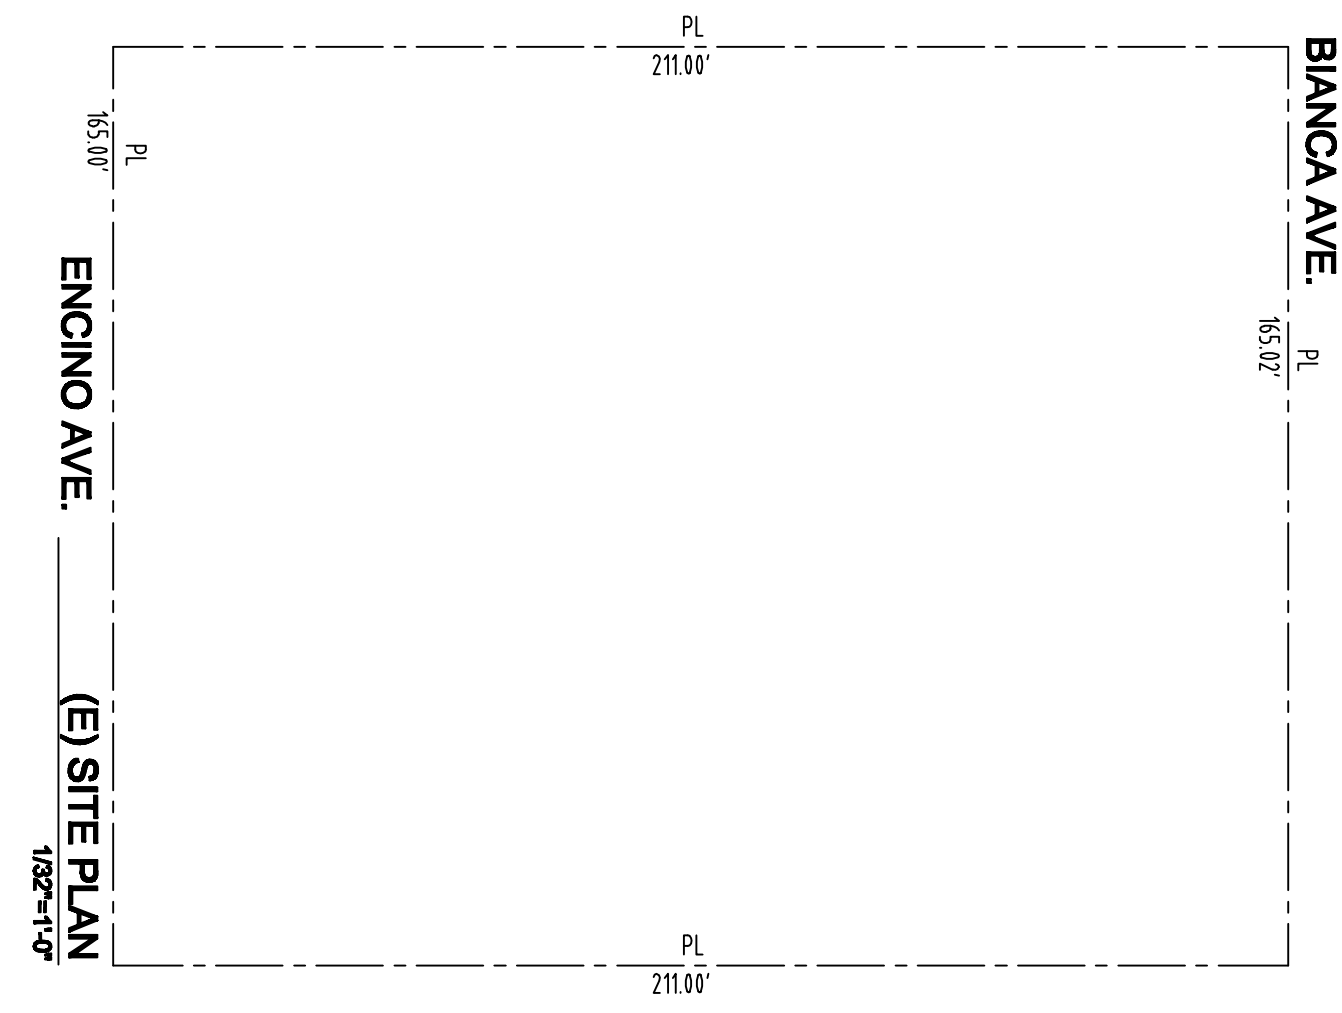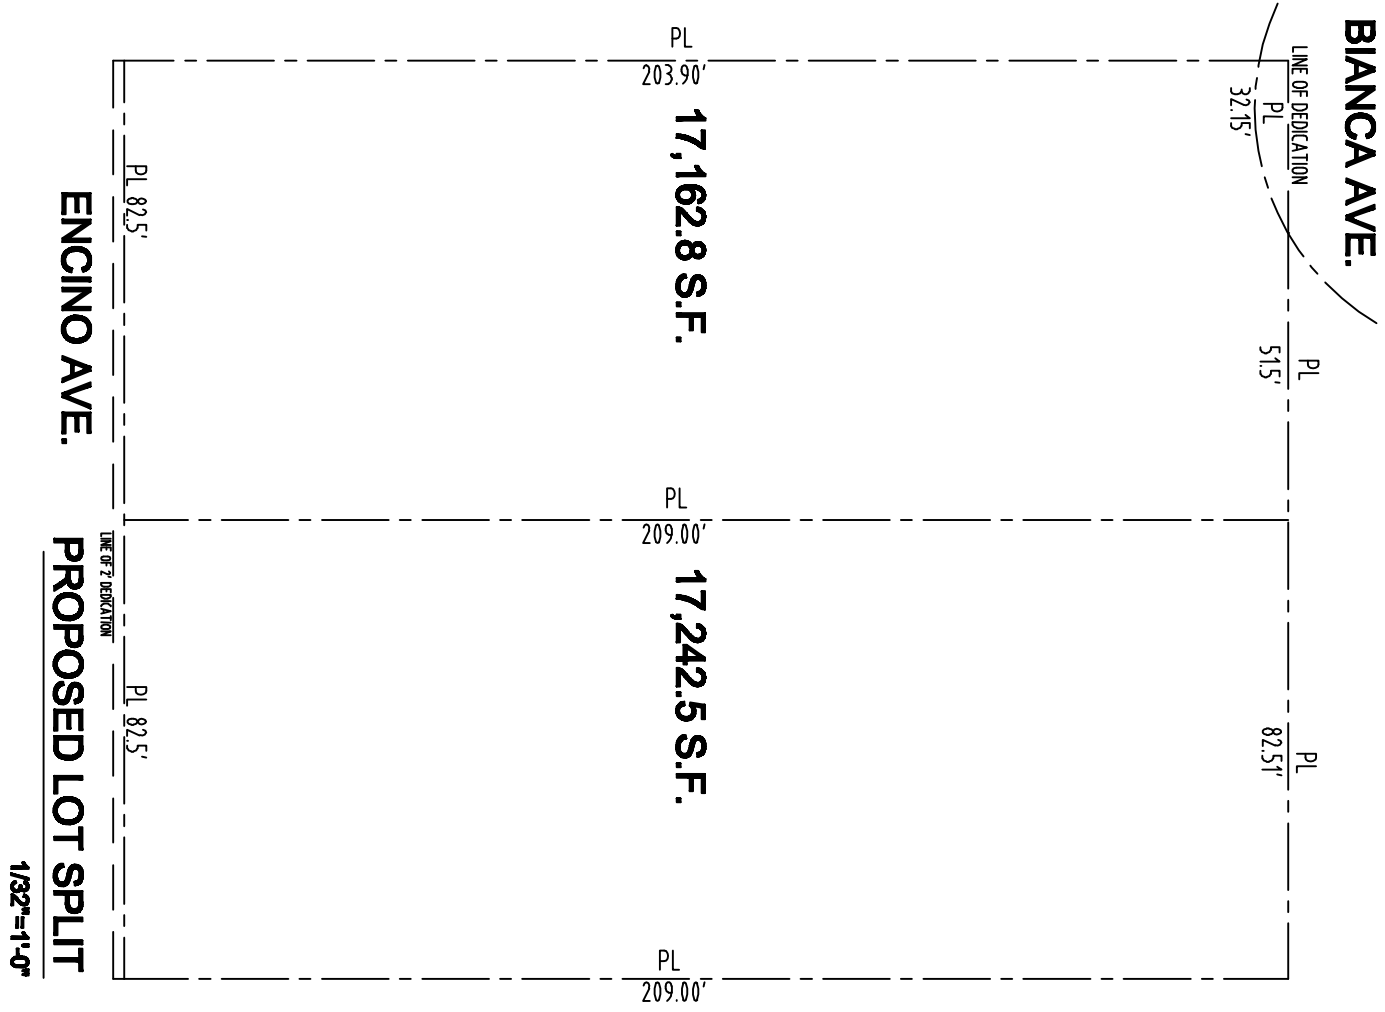

(E) SITE PLAN
 1/32"=1'-0"